

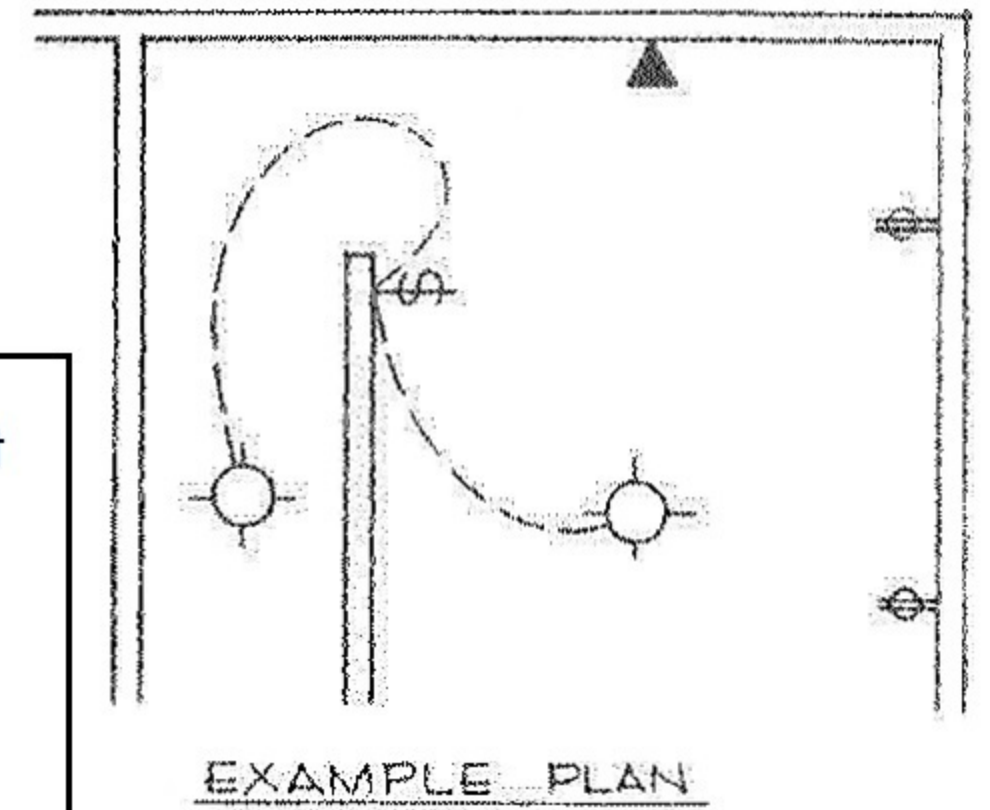
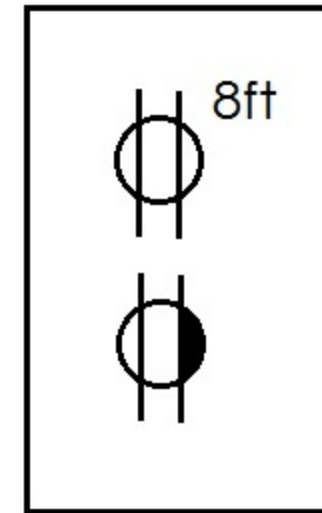
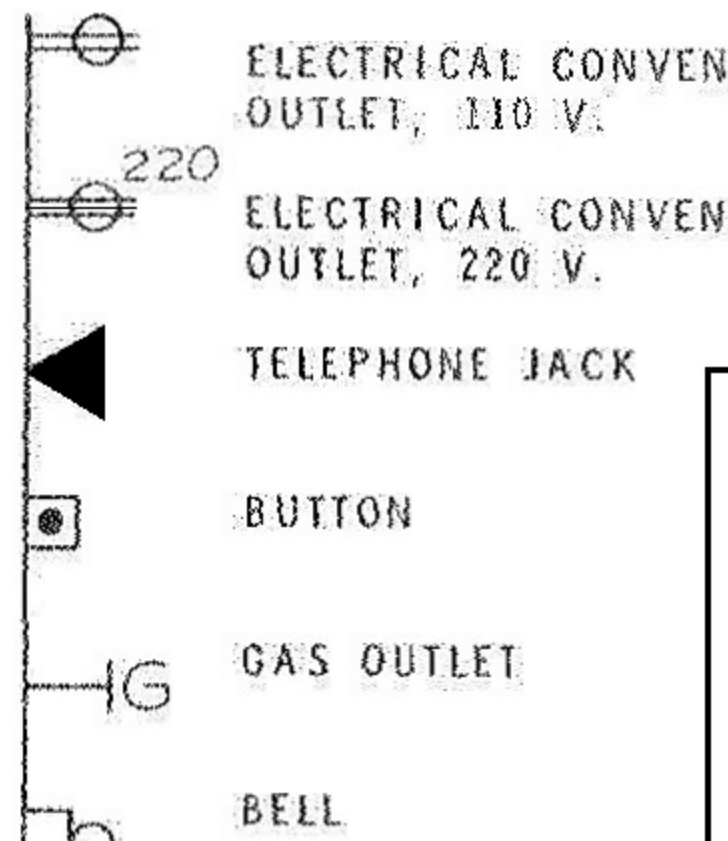


ELECTRICAL PLAN

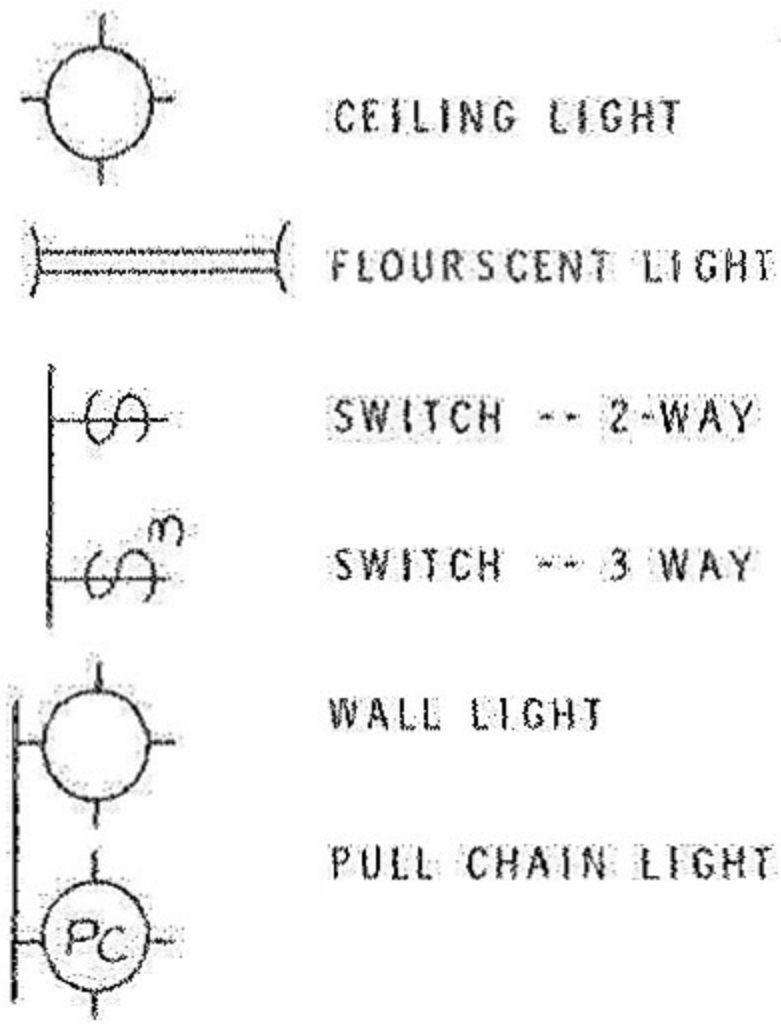

COMPLETE THE FLOOR PLAN BELOW BY SHOWING ALL ELECTRICAL SYMBOLS AND LIGHTS. PROVIDE FOR BOTH GAS AND ELECTRICAL AIR CONDITIONER AND RANGE.

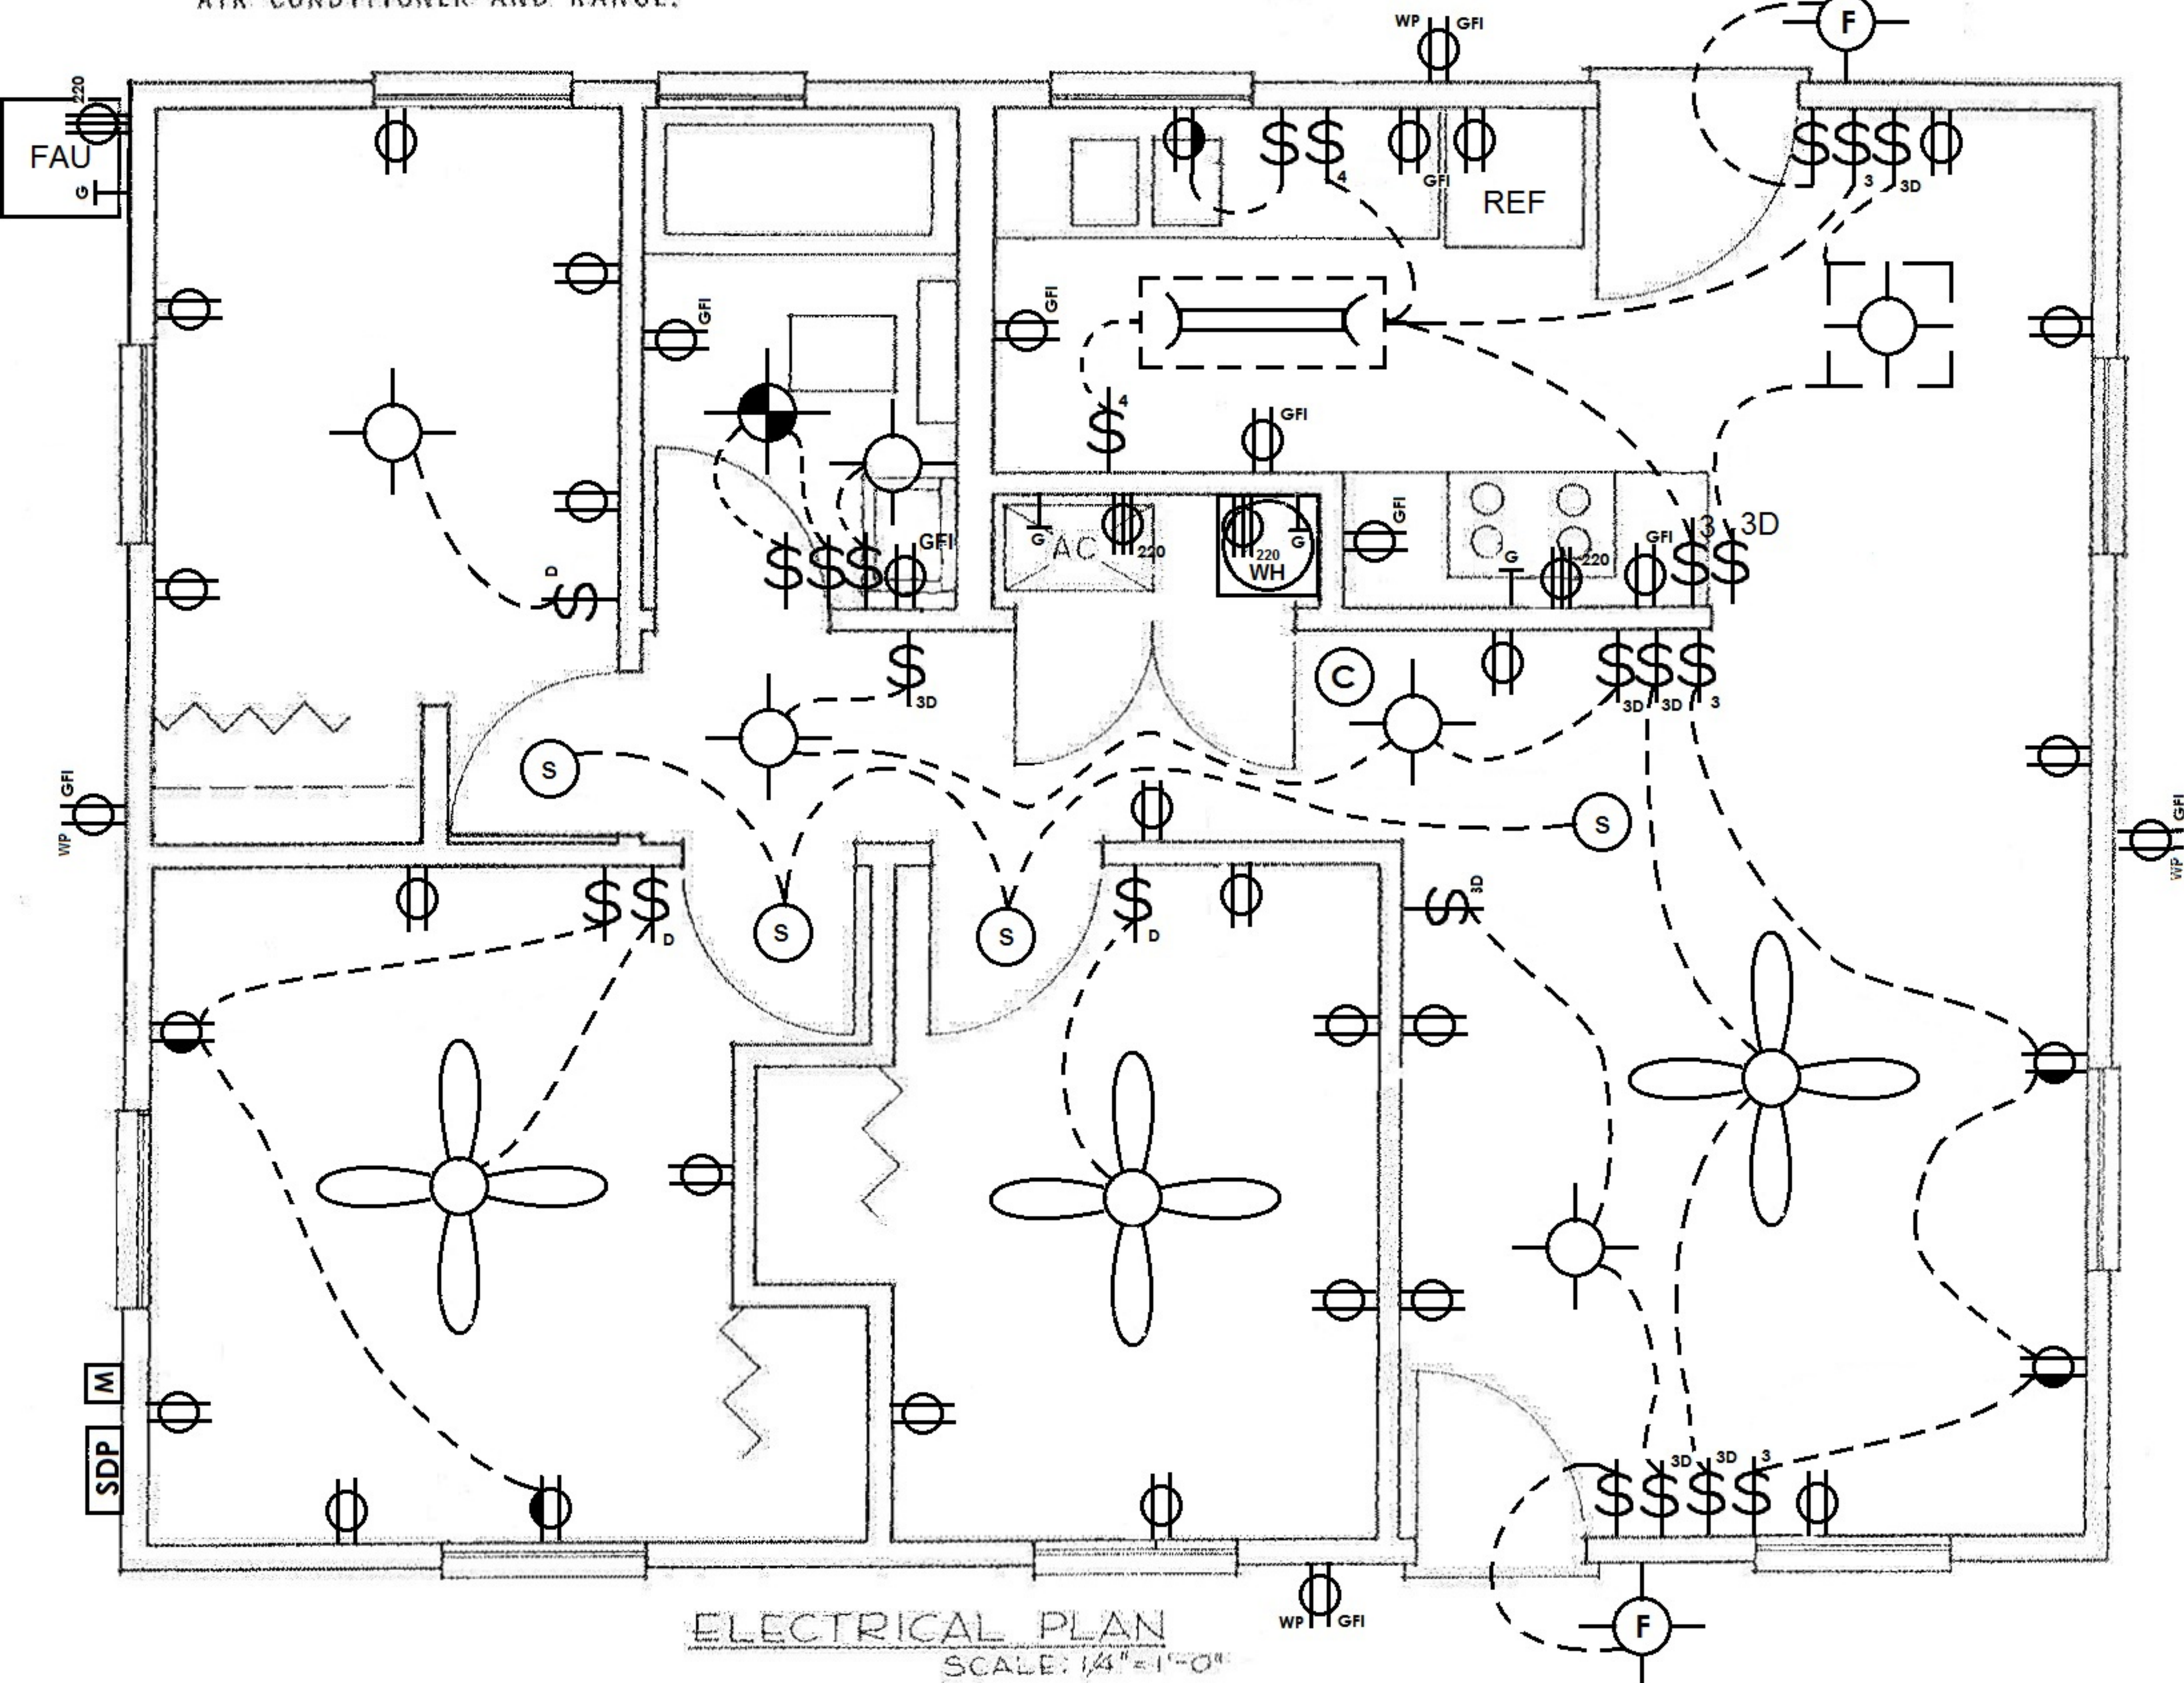

ELECTRICAL PLAN

SCALE: 1/4" = 1'-0"

Architectural Drafting

NAME

FILE NO

SEC

DATE

minutes grade

19